



SHEET INDEX

General

- G1.0 Cover Sheet & Index
- G2.0 Overall Floor Plan

Architectural

- D.1 Demolition Plan
- A1.1 First Floor New Construction
- A1.2 Floor Plan Elevations
- A1.3 Finish Plan
- A1.4 Schedules/Finishes

Mechanical

- M1.0 Mechanical Plan
- M2.0 Mechanical Elevations
- M3.0 Existing HVAC Ductwork 1st Floor
- M4.0 Existing HVAC Piping 1st Floor

Electrical

- E1 Reflected Ceiling Plan
- E2 Power & Systems Plan



3500 John A. Merritt Blvd.  
Nashville, TN 37209  
P 615.963.7755  
F 615.963.7434  
[www.tnstate.edu](http://www.tnstate.edu)

LRC Lobby Renovation

TSU

Project Number LRC-0001

Date 7/27/2011


REVISION INFORMATION

COVER SHEET

G1.0

TENNESSEE STATE UNIVERSITY

LRC Lobby  
Renovation

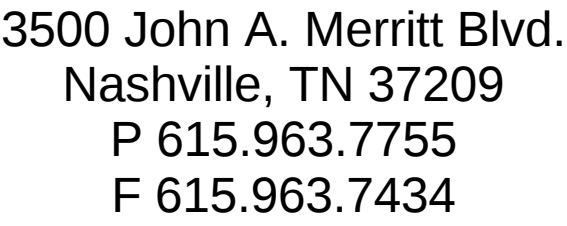

# LRC Lobby Renovation

[illegible]

## Demo Plan


|                |            |
|----------------|------------|
| Project Number | LRC-0003   |
| Date           | 7/27/2011  |
| Drawn By       | F. Jolivet |
| Checked By     | Checke     |

# D1.1

Scale  $1/8" = 1'-0"$

- D1 Demo all walls as indicated. Relocate fire alarm panel (to be done by others).
- D2 Remove doors as indicated (Doors to be given to Owner)
- D3 Remove existing water fountain (Water fountain to be given to Owner)
- D4 Remove existing dark room sinks and equipment (Cut/Cap all supply & drain lines as close to wall surface as possible)
- D5 Remove all countertops & supports as indicated
- D6 Demo/remove existing stairs. Wall finish needs to be acceptable to receive paint.
- D7 Demo existing ceiling grid
- D8 Remove all crown molding
- D9 Remove all existing VCT flooring in area
- D10 Demo and Cap Existing piping
- D11 Demo existing ceiling partition/Leave piping and electric to install new fan coil unit
- D12 Remove / Relocate Fire Extinguisher Cabinet (new location TBD by Owner)



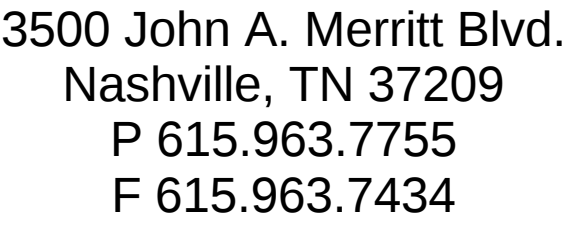

# LRC Lobby Renovation

 

 
[illegible]

## First Floor - New Construction

|                |             |
|----------------|-------------|
| Project Number | LRC-000     |
| Date           | 7/27/201    |
| Drawn By       | F. JOLIVETT |
| Checked By     | Checke      |

# A1.1

Scale As indicated

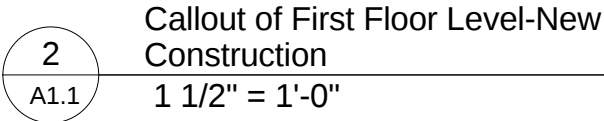

- 1 RELOCATION OF FIRE EXTINGUISHER CABINET
- 2 RELOCATION OF FIRE ALARM PANEL
- 3 CLOSE WALL OPENING

| WALL TYPE LEGEND |                               |
|------------------|-------------------------------|
| =====            | EXISTING COMPONENTS TO REMAIN |
| =====            | NEW METAL STUD WALL PARTITION |
| -----            | OVERHEAD SOFFIT WALL          |



3500 John A. Merritt Blvd.  
Nashville, TN 37209  
P 615.963.7755  
F 615.963.7434

www.tnstate.edu

# LRC Lobby Renovation

| No. | Description | Date    |
|-----|-------------|---------|
| 1   | Revision 1  | 7-21-11 |
| 2   | Revision 2  | 8-19-11 |
| 3   | Revision 3  | 8-23-11 |
|     |             |         |
|     |             |         |
|     |             |         |
|     |             |         |
|     |             |         |
|     |             |         |
|     |             |         |
|     |             |         |

TSU


Elevations

|                |              |
|----------------|--------------|
| Project Number | LRC-0001     |
| Date           | 7/27/2011    |
| Drawn By       | F. Jolivette |
| Checked By     | Checker      |


A1.2

Scale 1/4" = 1'-0"


8/24/2011 8:37:54 AM

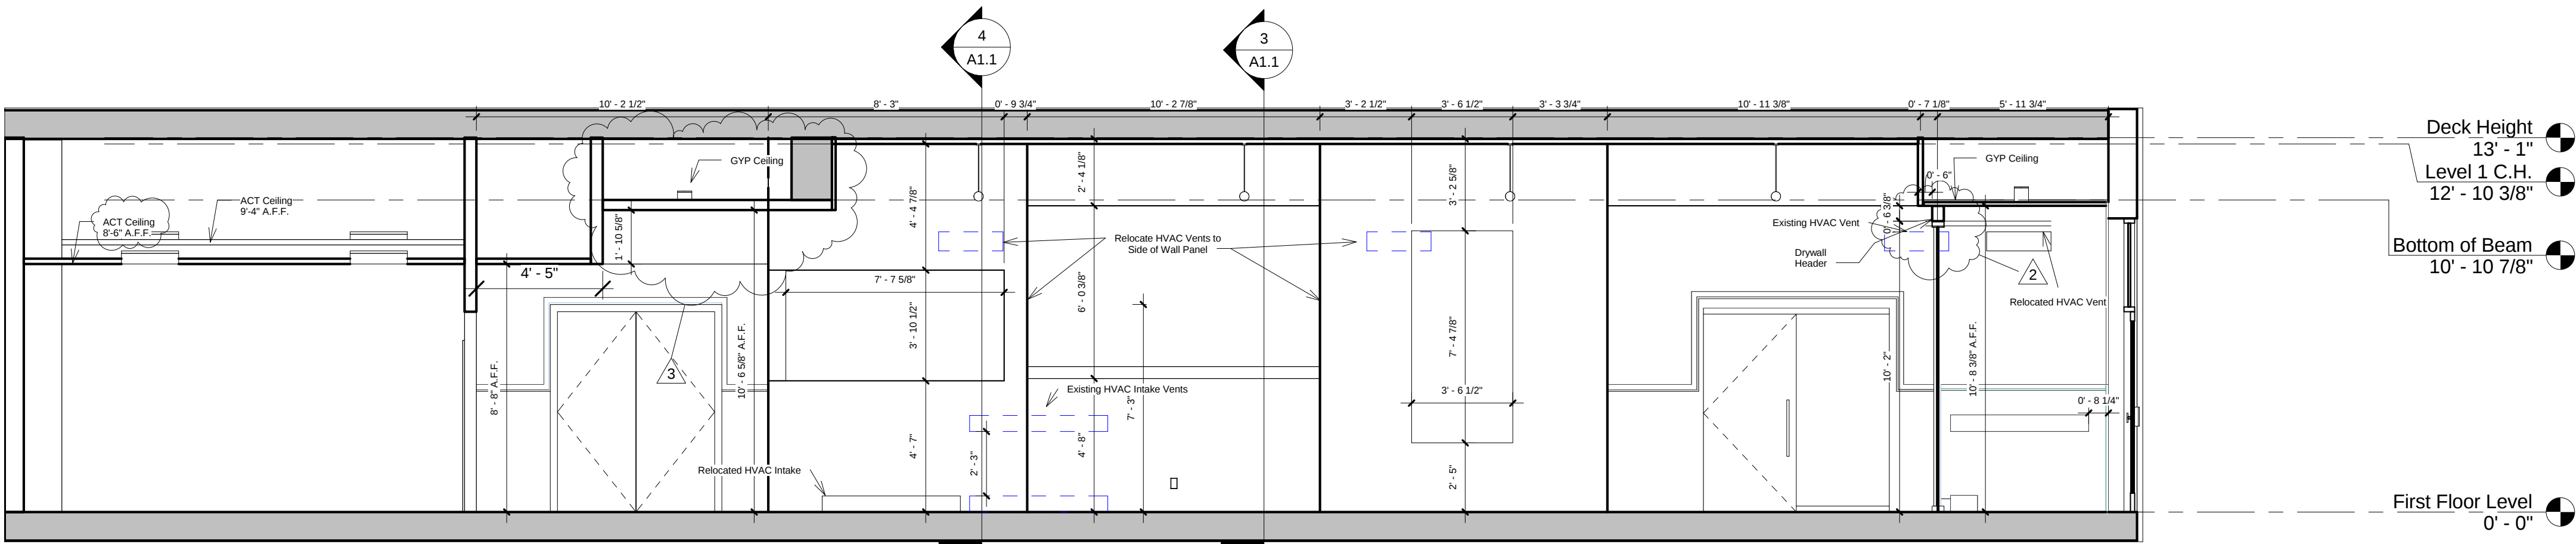


1  
A1.1  
Elevation 1 - East Wall  
1/4" = 1'-0"

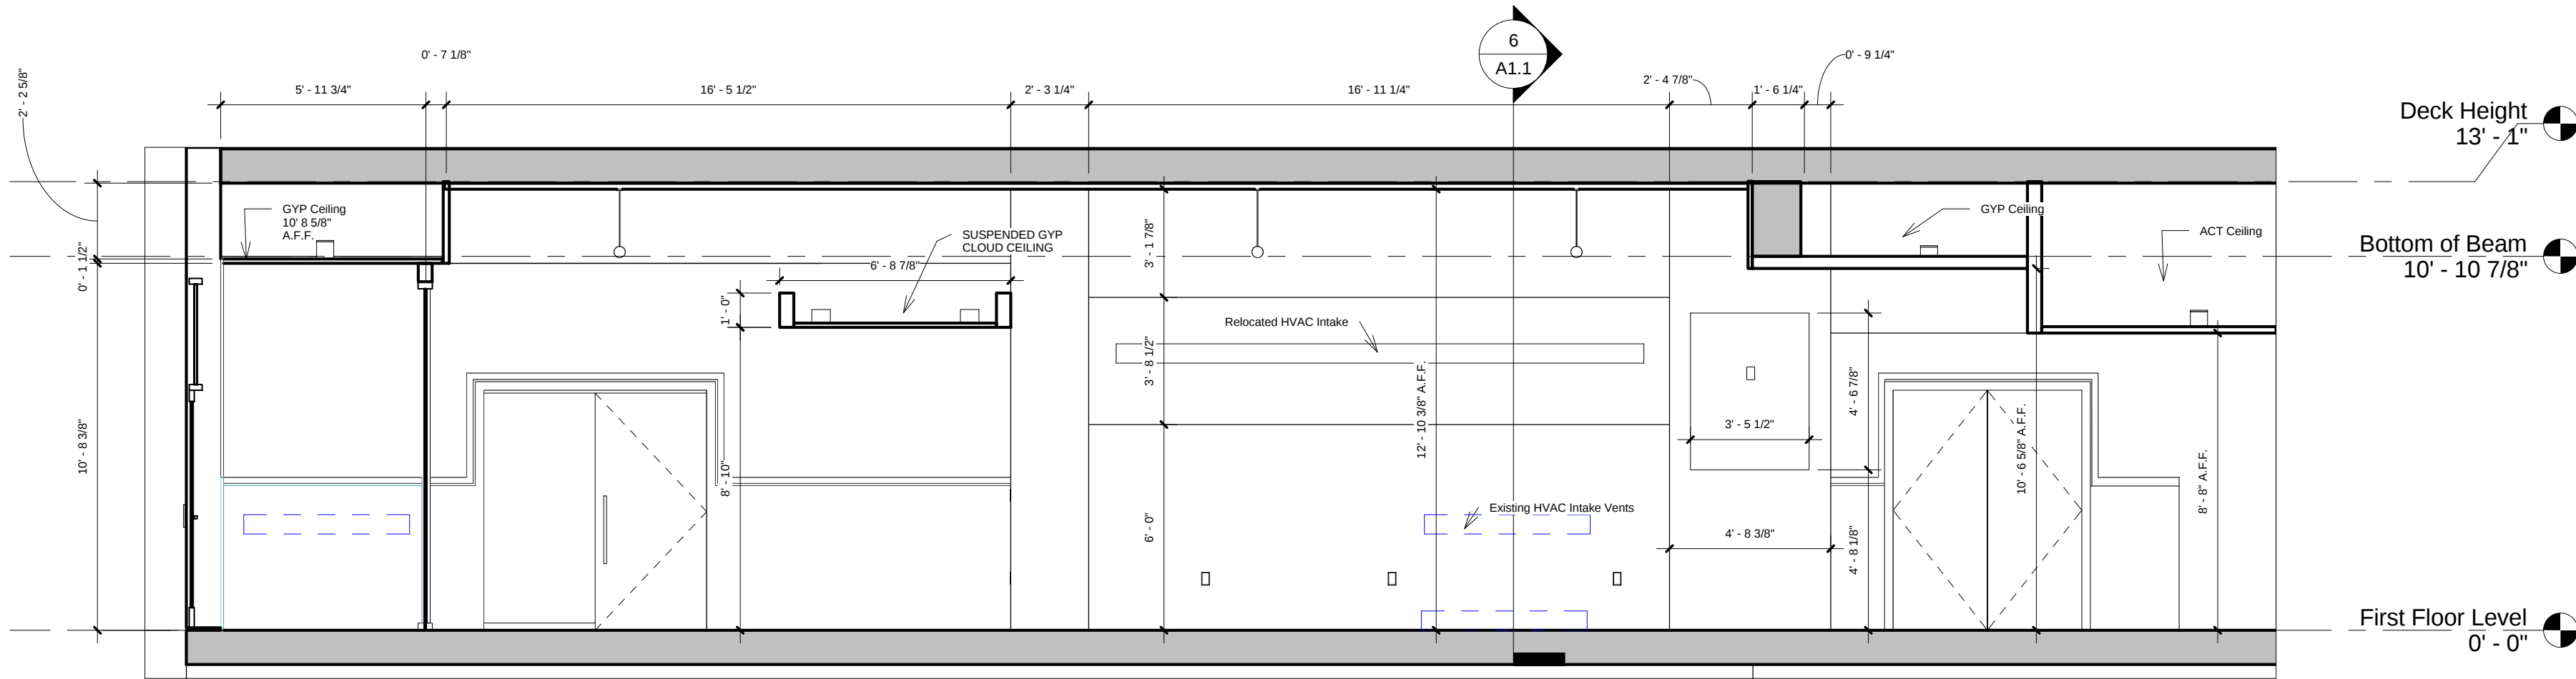


2  
A1.1  
Elevation 2 - West Wall  
1/4" = 1'-0"

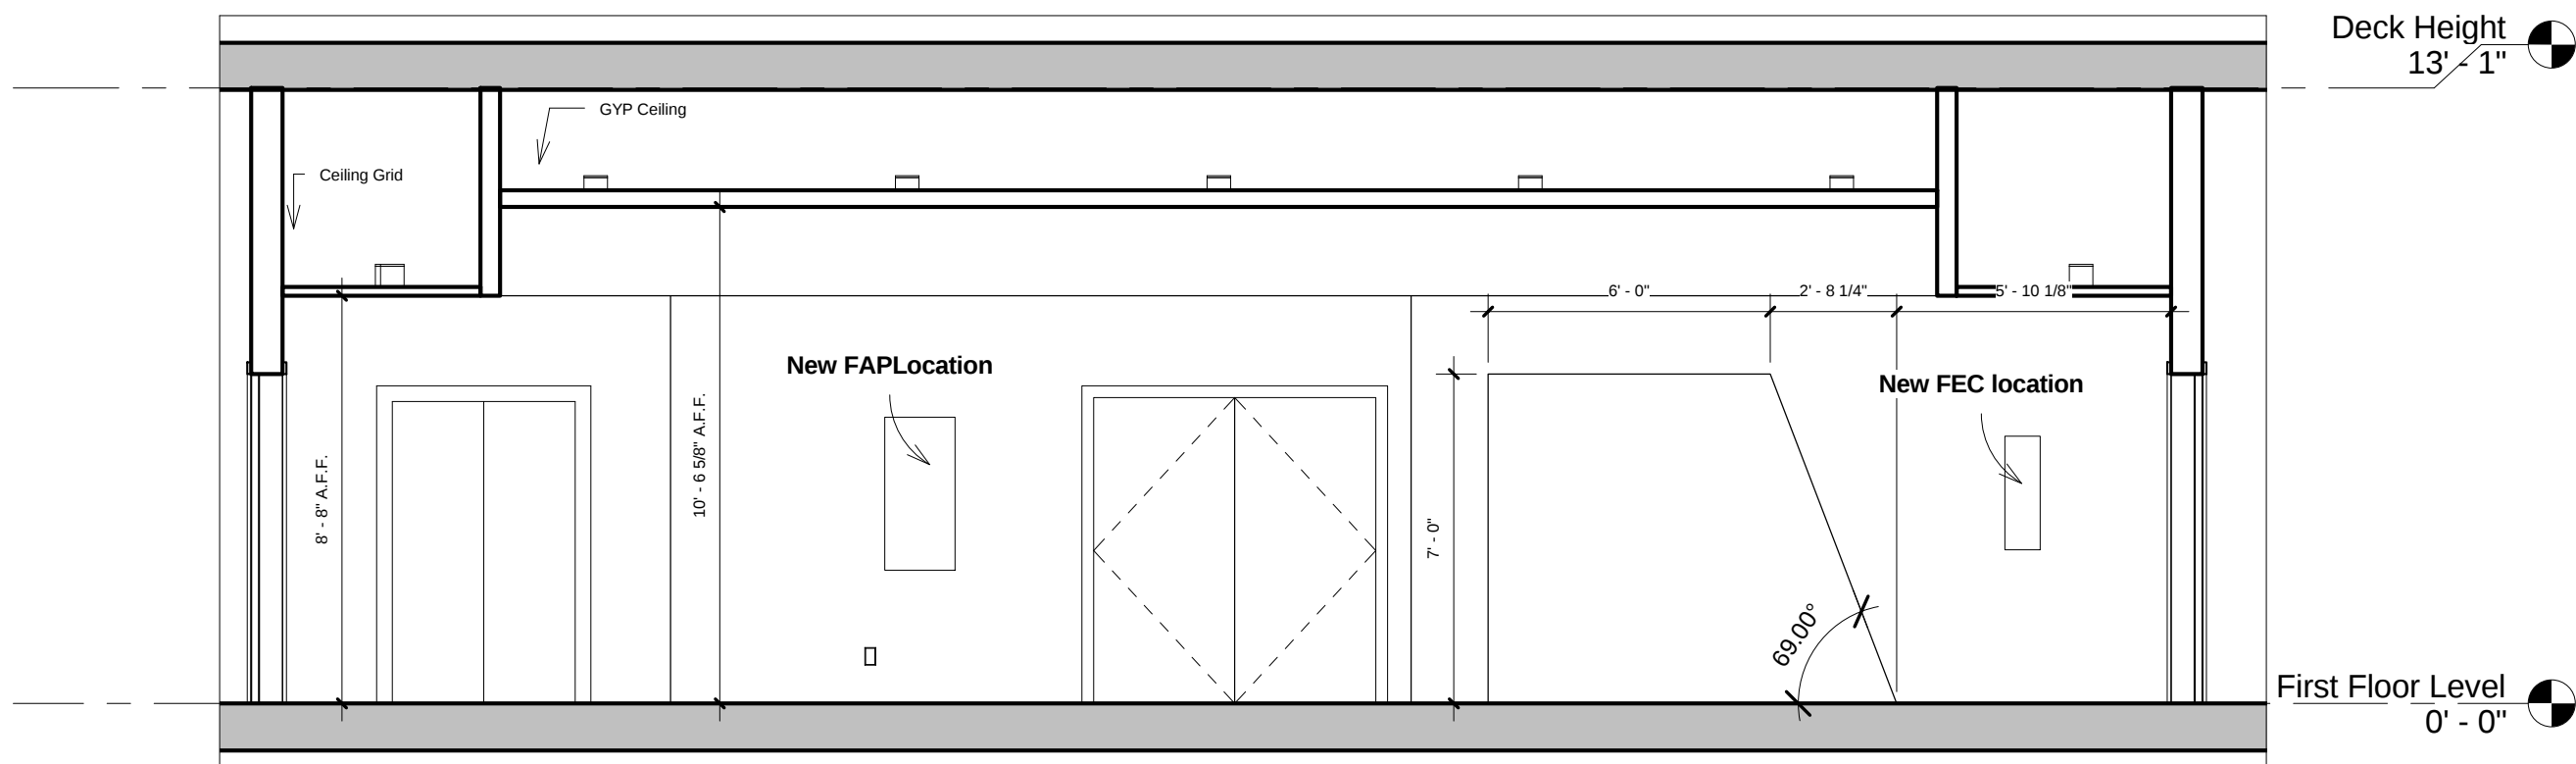

4  
A1.1  
Elevation 1 - a  
1/4" = 1'-0"

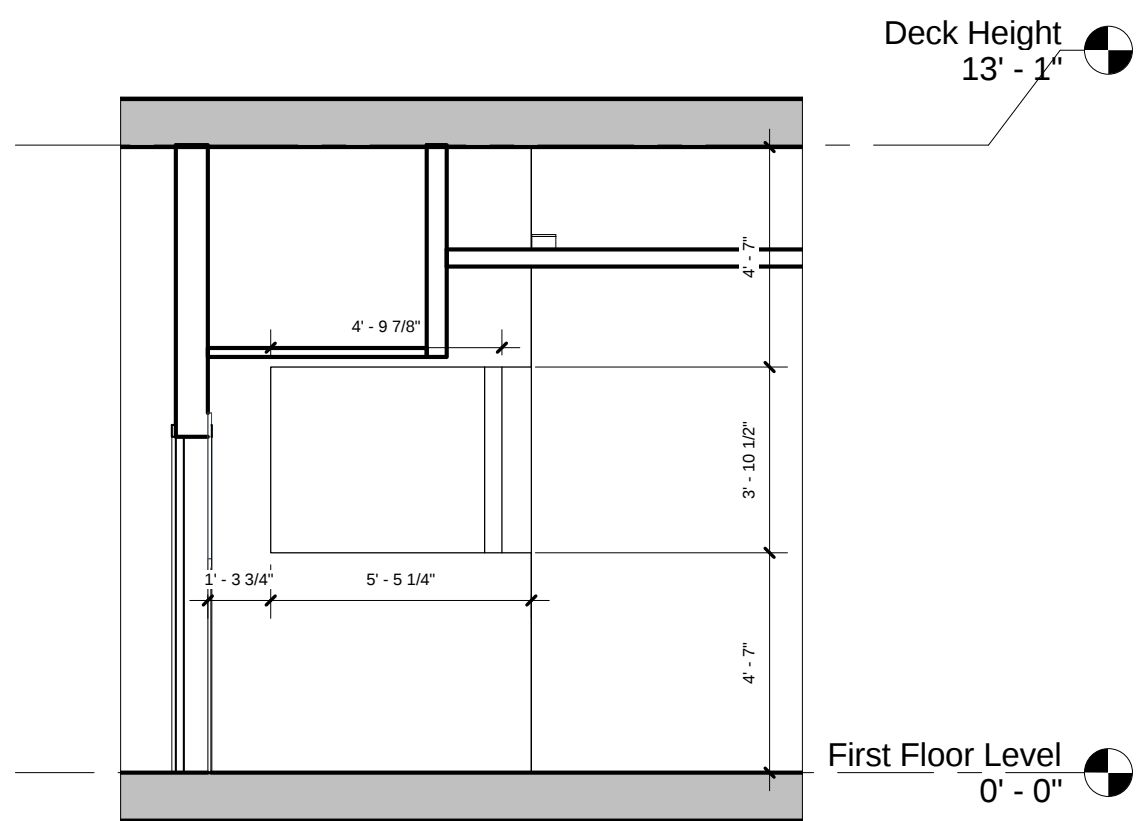

3  
A1.1  
Elevation 3 - South Wall  
1/4" = 1'-0"

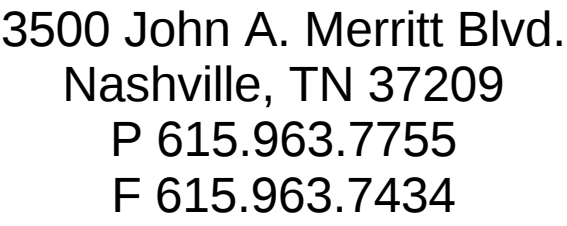

# LRC Lobby Renovation


[illegible]

## FINISH PLAN


|                |             |
|----------------|-------------|
| Project Number | LRC-000     |
| Date           | 7/27/201    |
| Drawn By       | F. Jolivett |
| Checked By     | Checke      |

## A1.3A

Scale As indicated

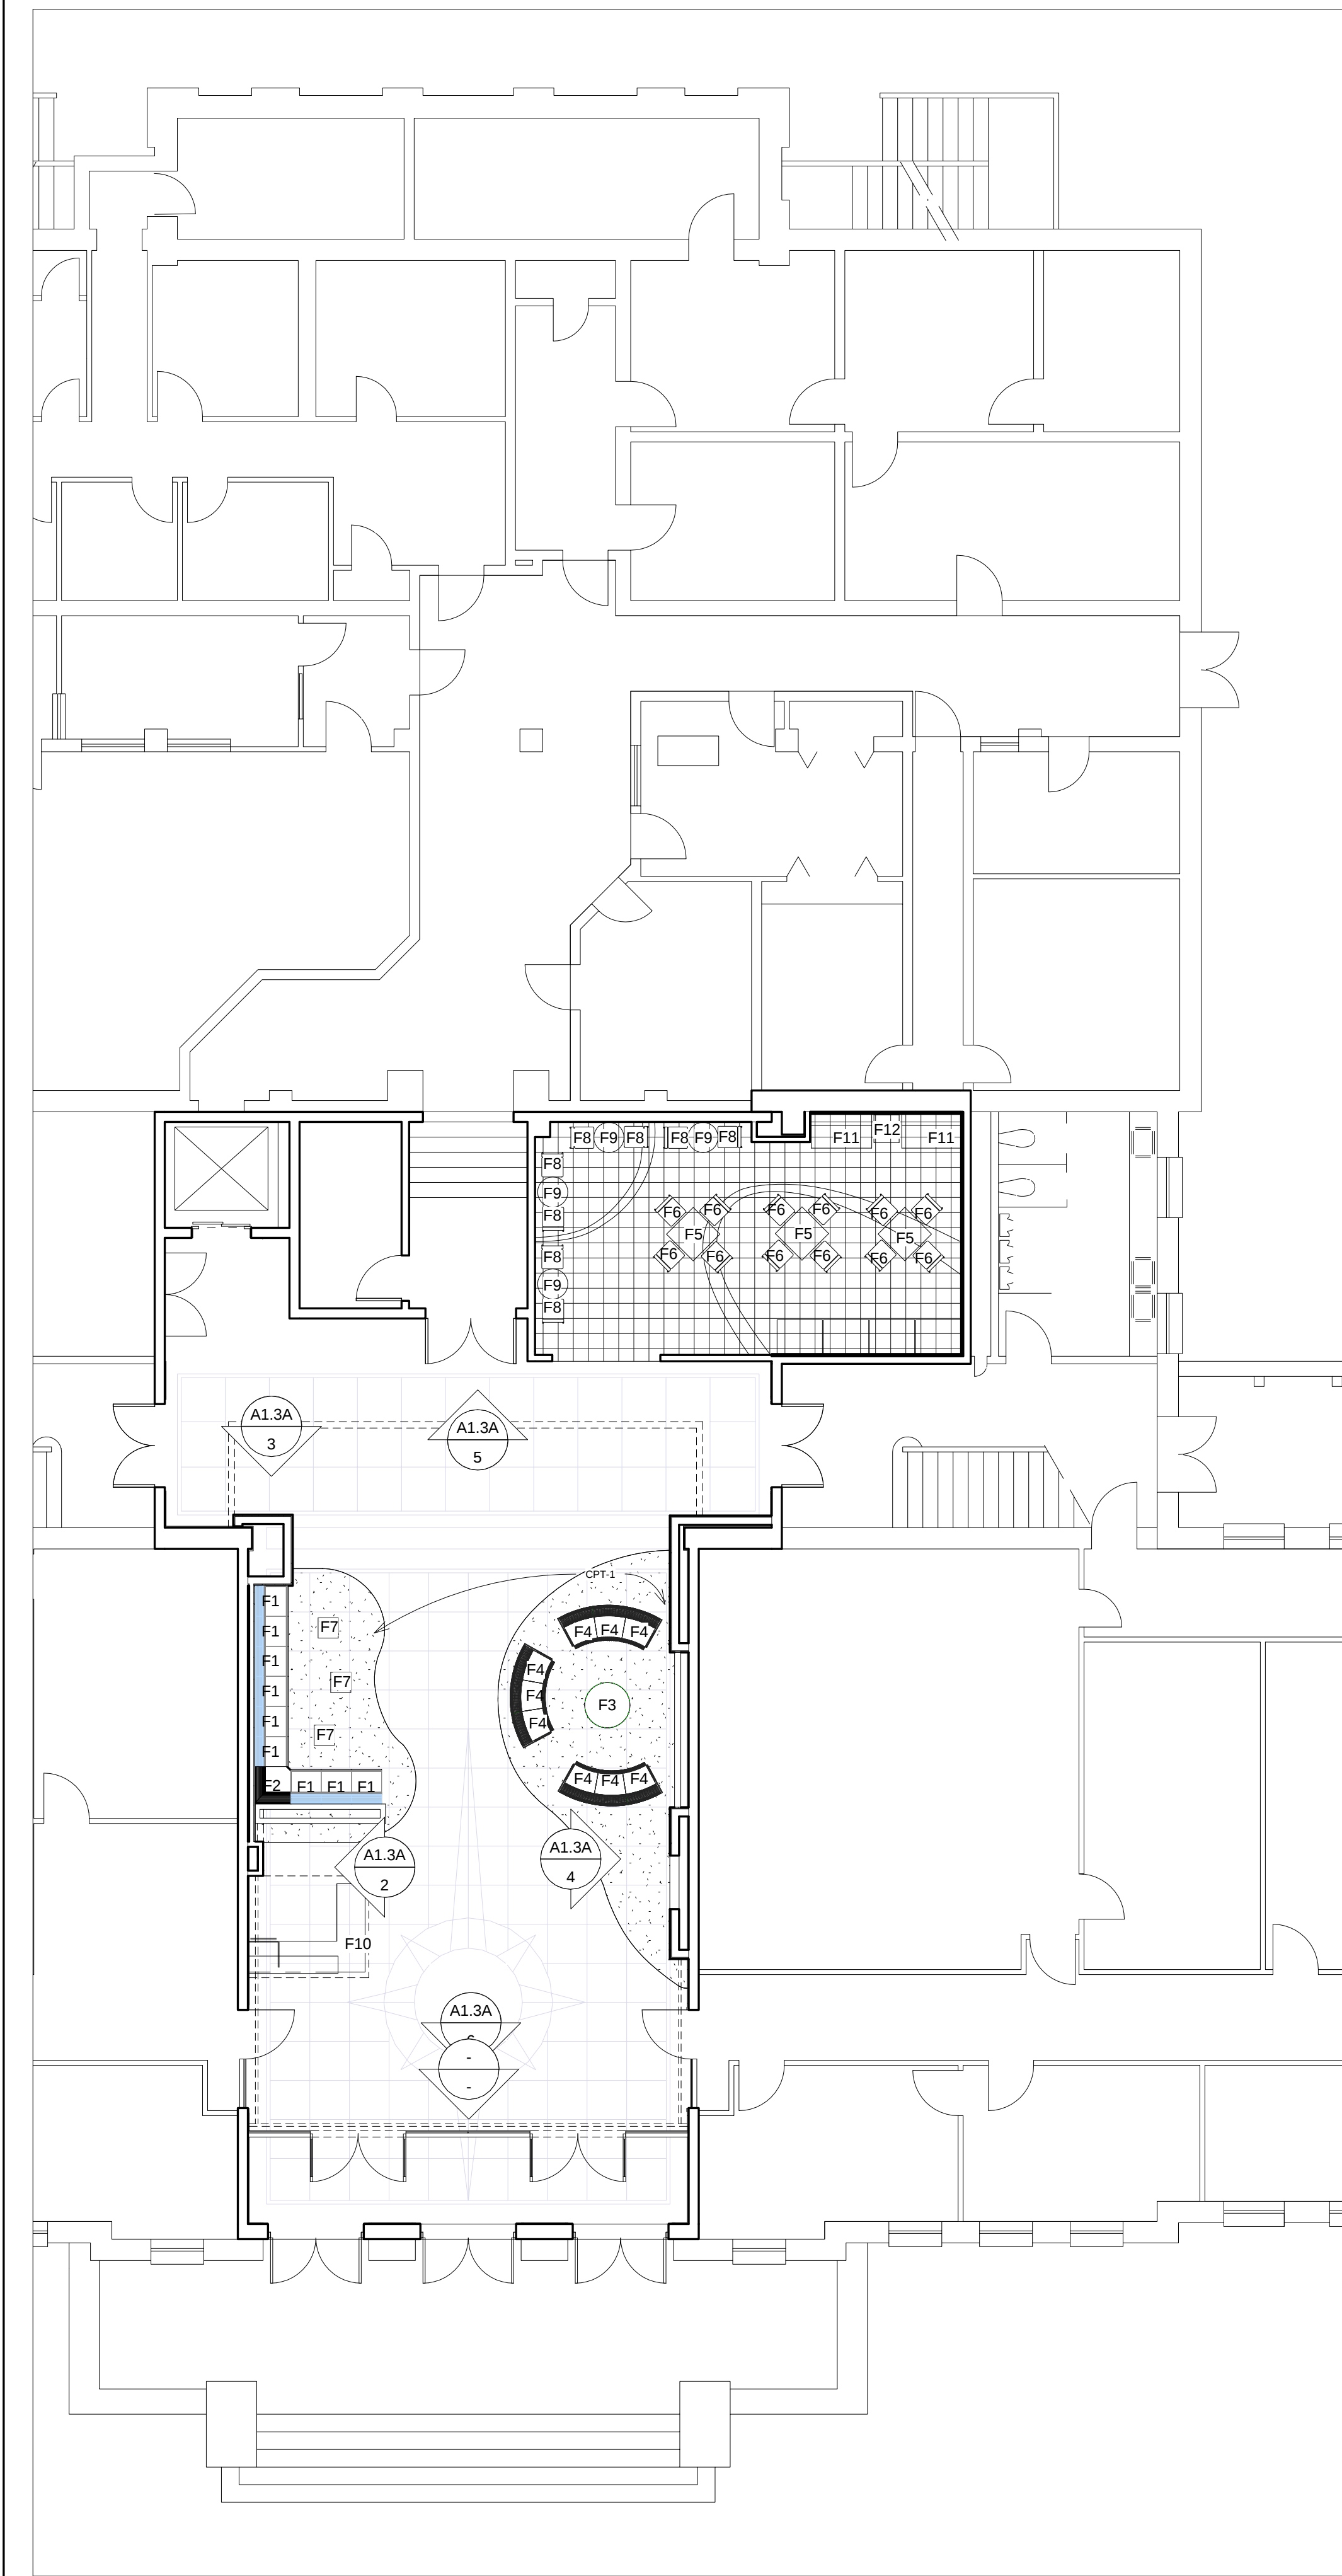

① First Floor Level-Furniture Plan  
1/8" = 1'-0"

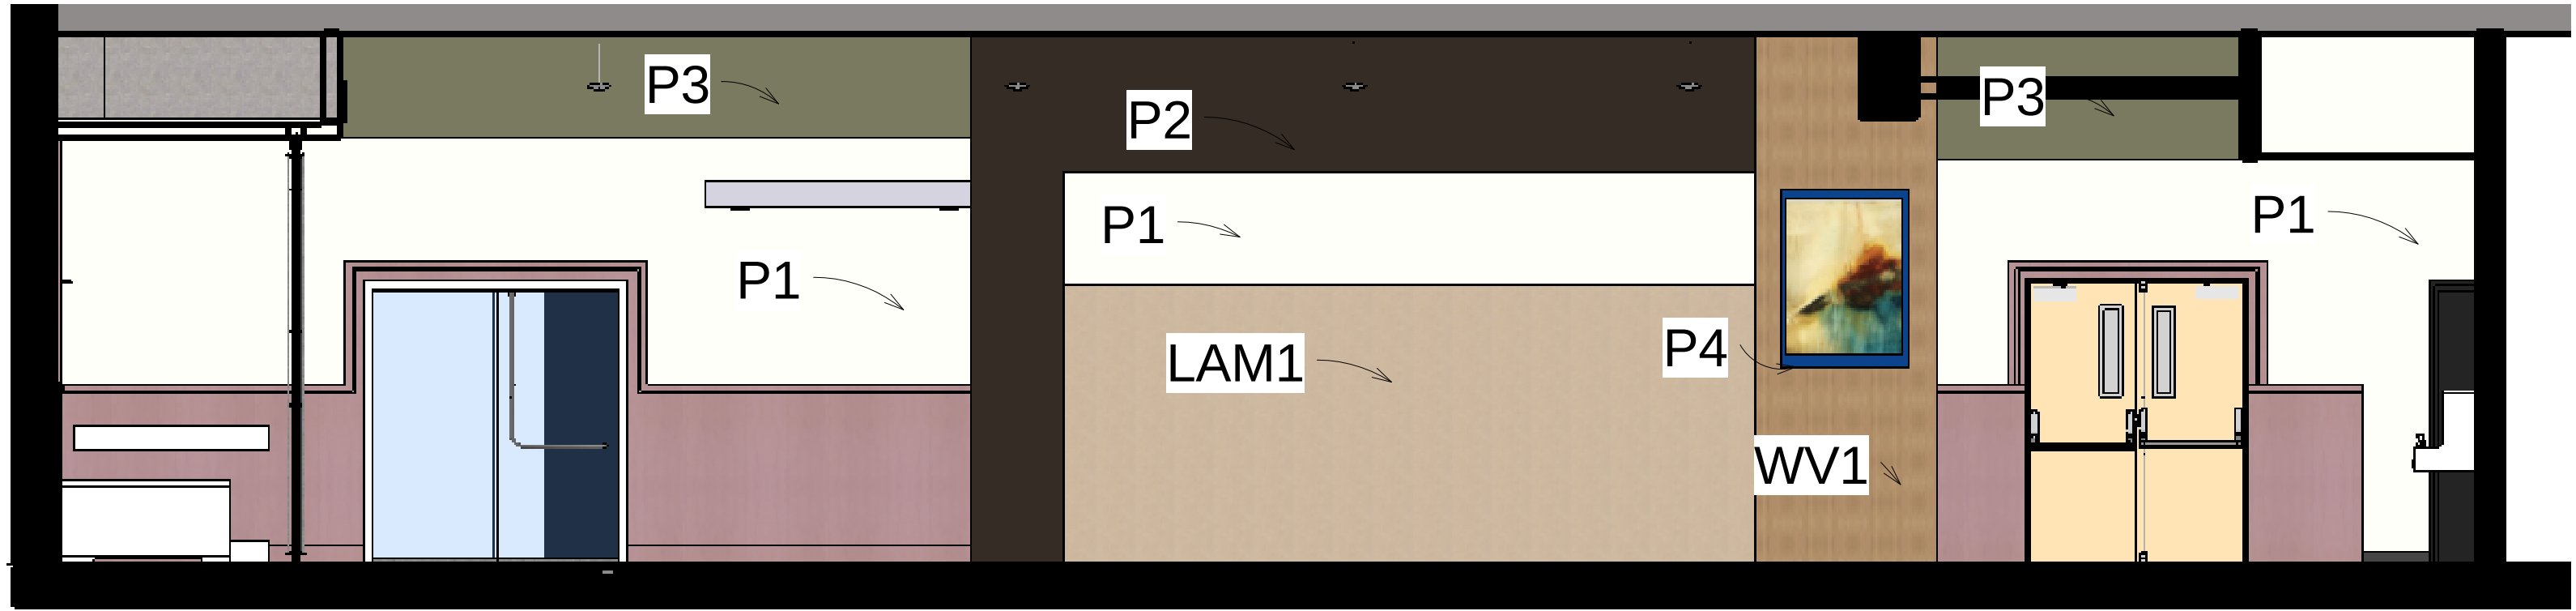

ELEVATION - 2

$1/8" = 1'-0"$




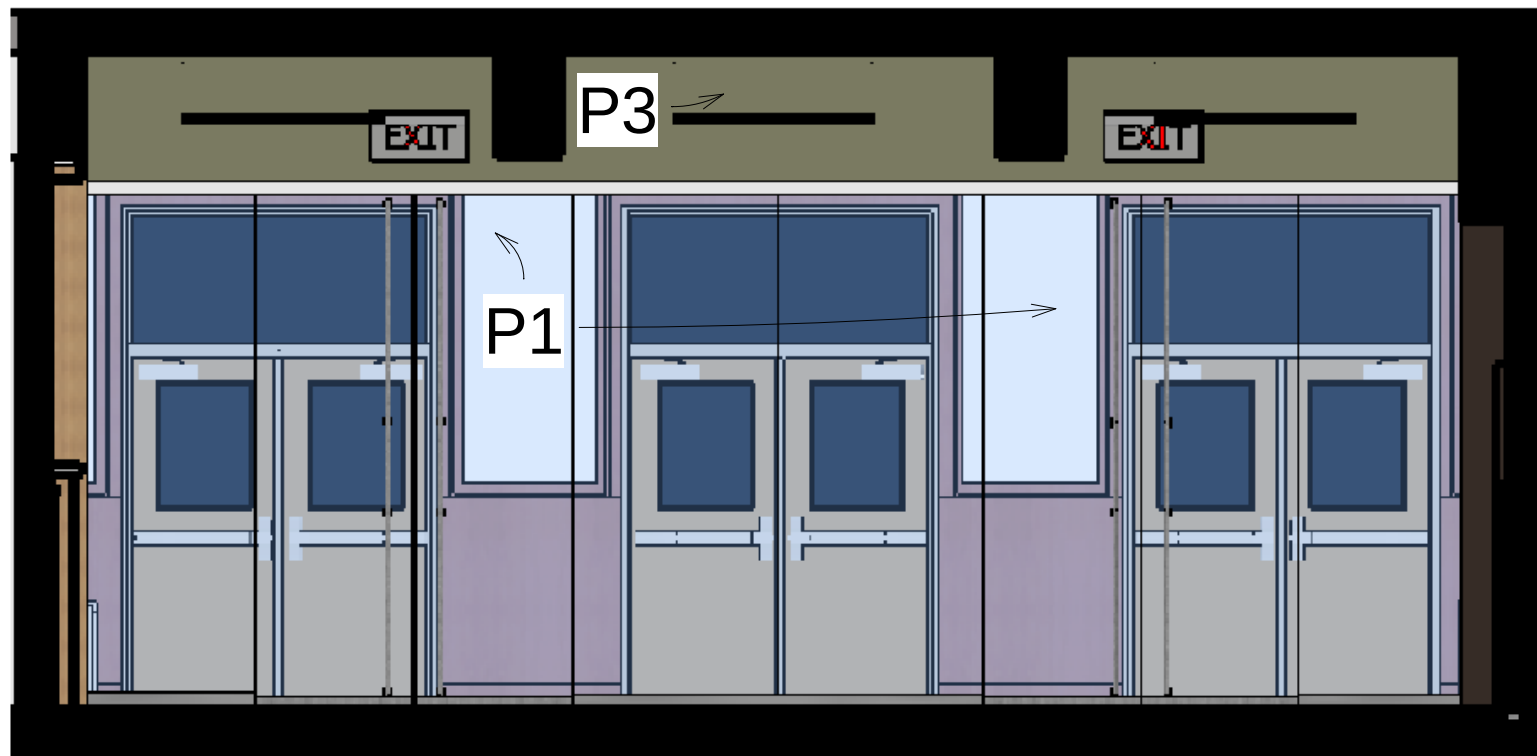


Diagram of a circular structure with a triangle on top. The triangle has a base of 6 and a height of 1.3. The circle has a diameter of 1.8 inches, which is equivalent to 1 foot 0 inches.

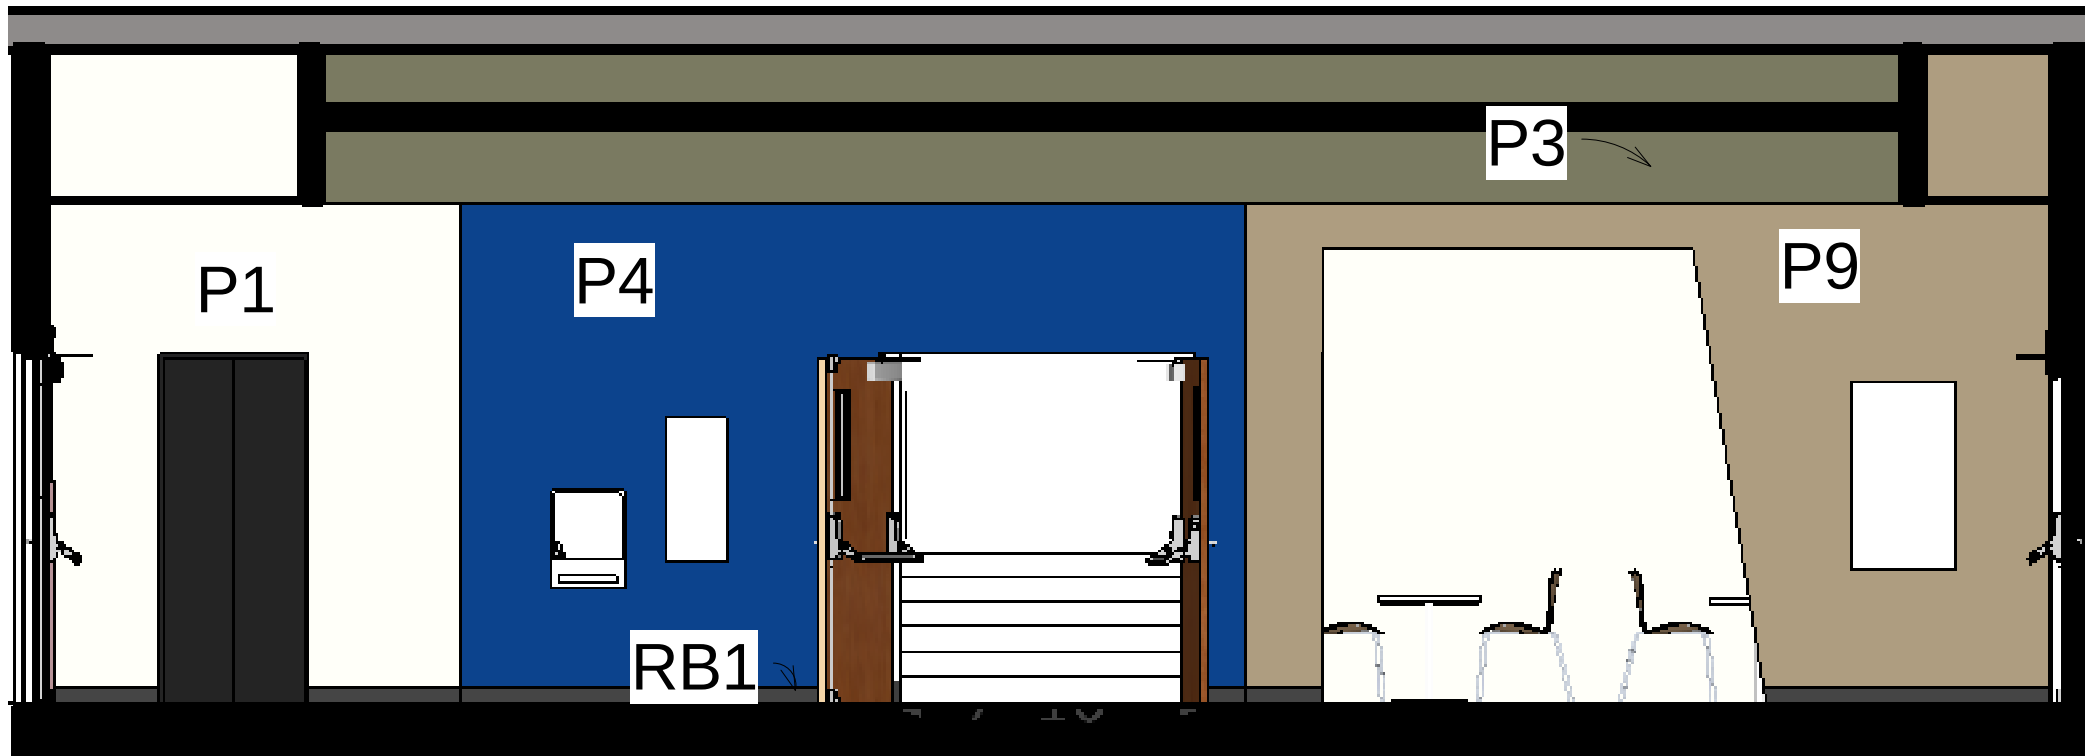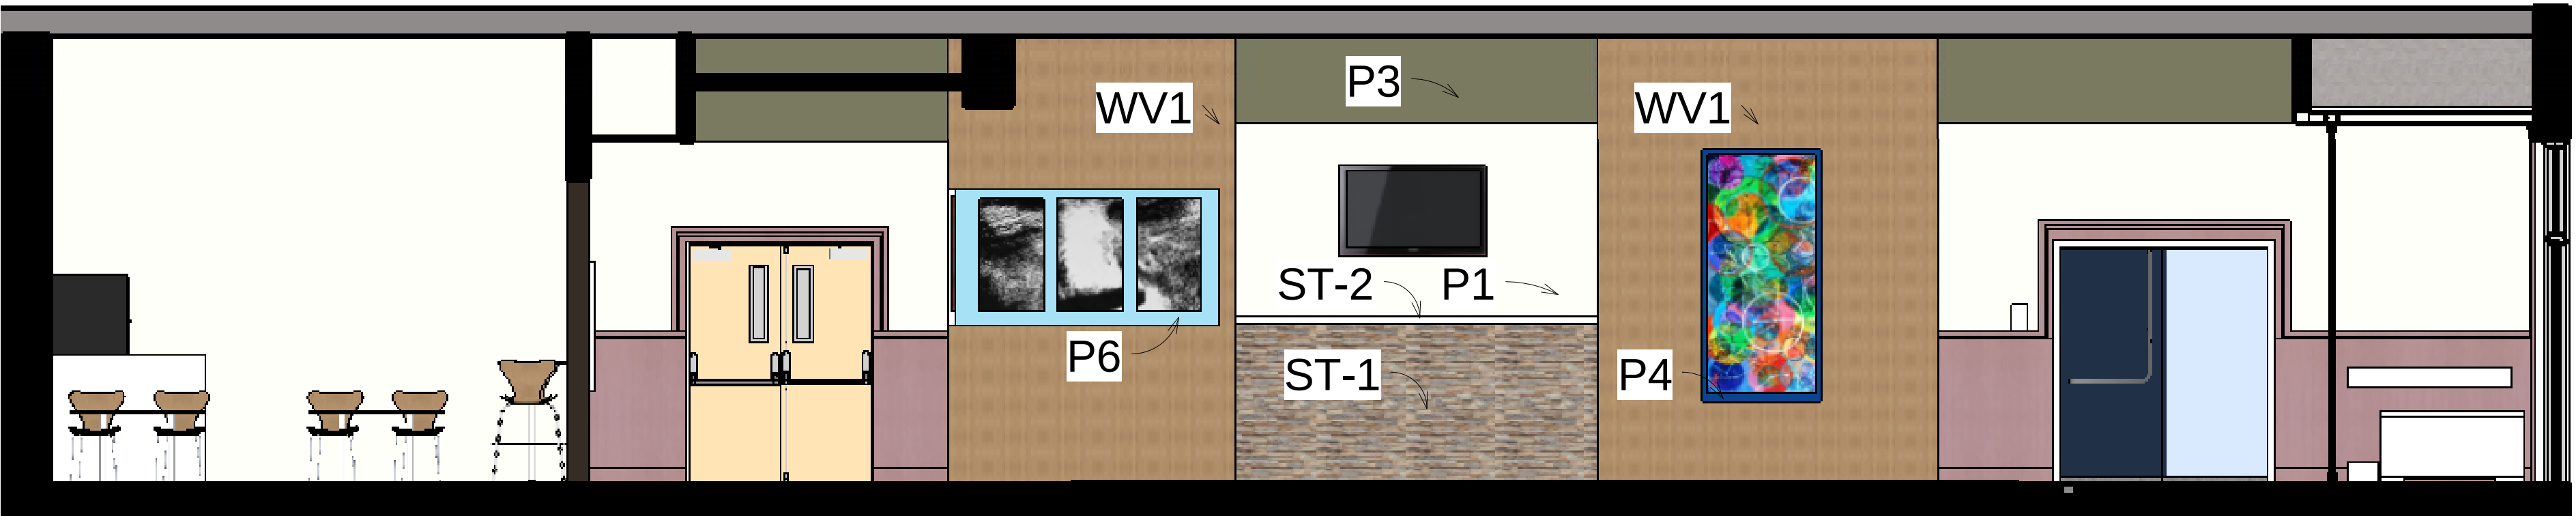


 LRC Lobby Interior - Perspective Elevation  
 NO SCALE

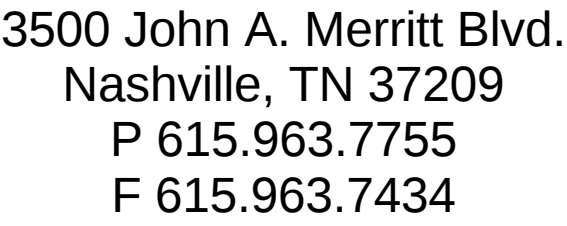

# LRC Lobby Renovation


[illegible]

## FINISH PLAN

|                |          |
|----------------|----------|
| Project Number | LRC-000  |
| Date           | 7/27/201 |
| Drawn By       | Autho    |
| Checked By     | Checke   |

# A1.3B

Scale  $3/8" = 1'-0"$

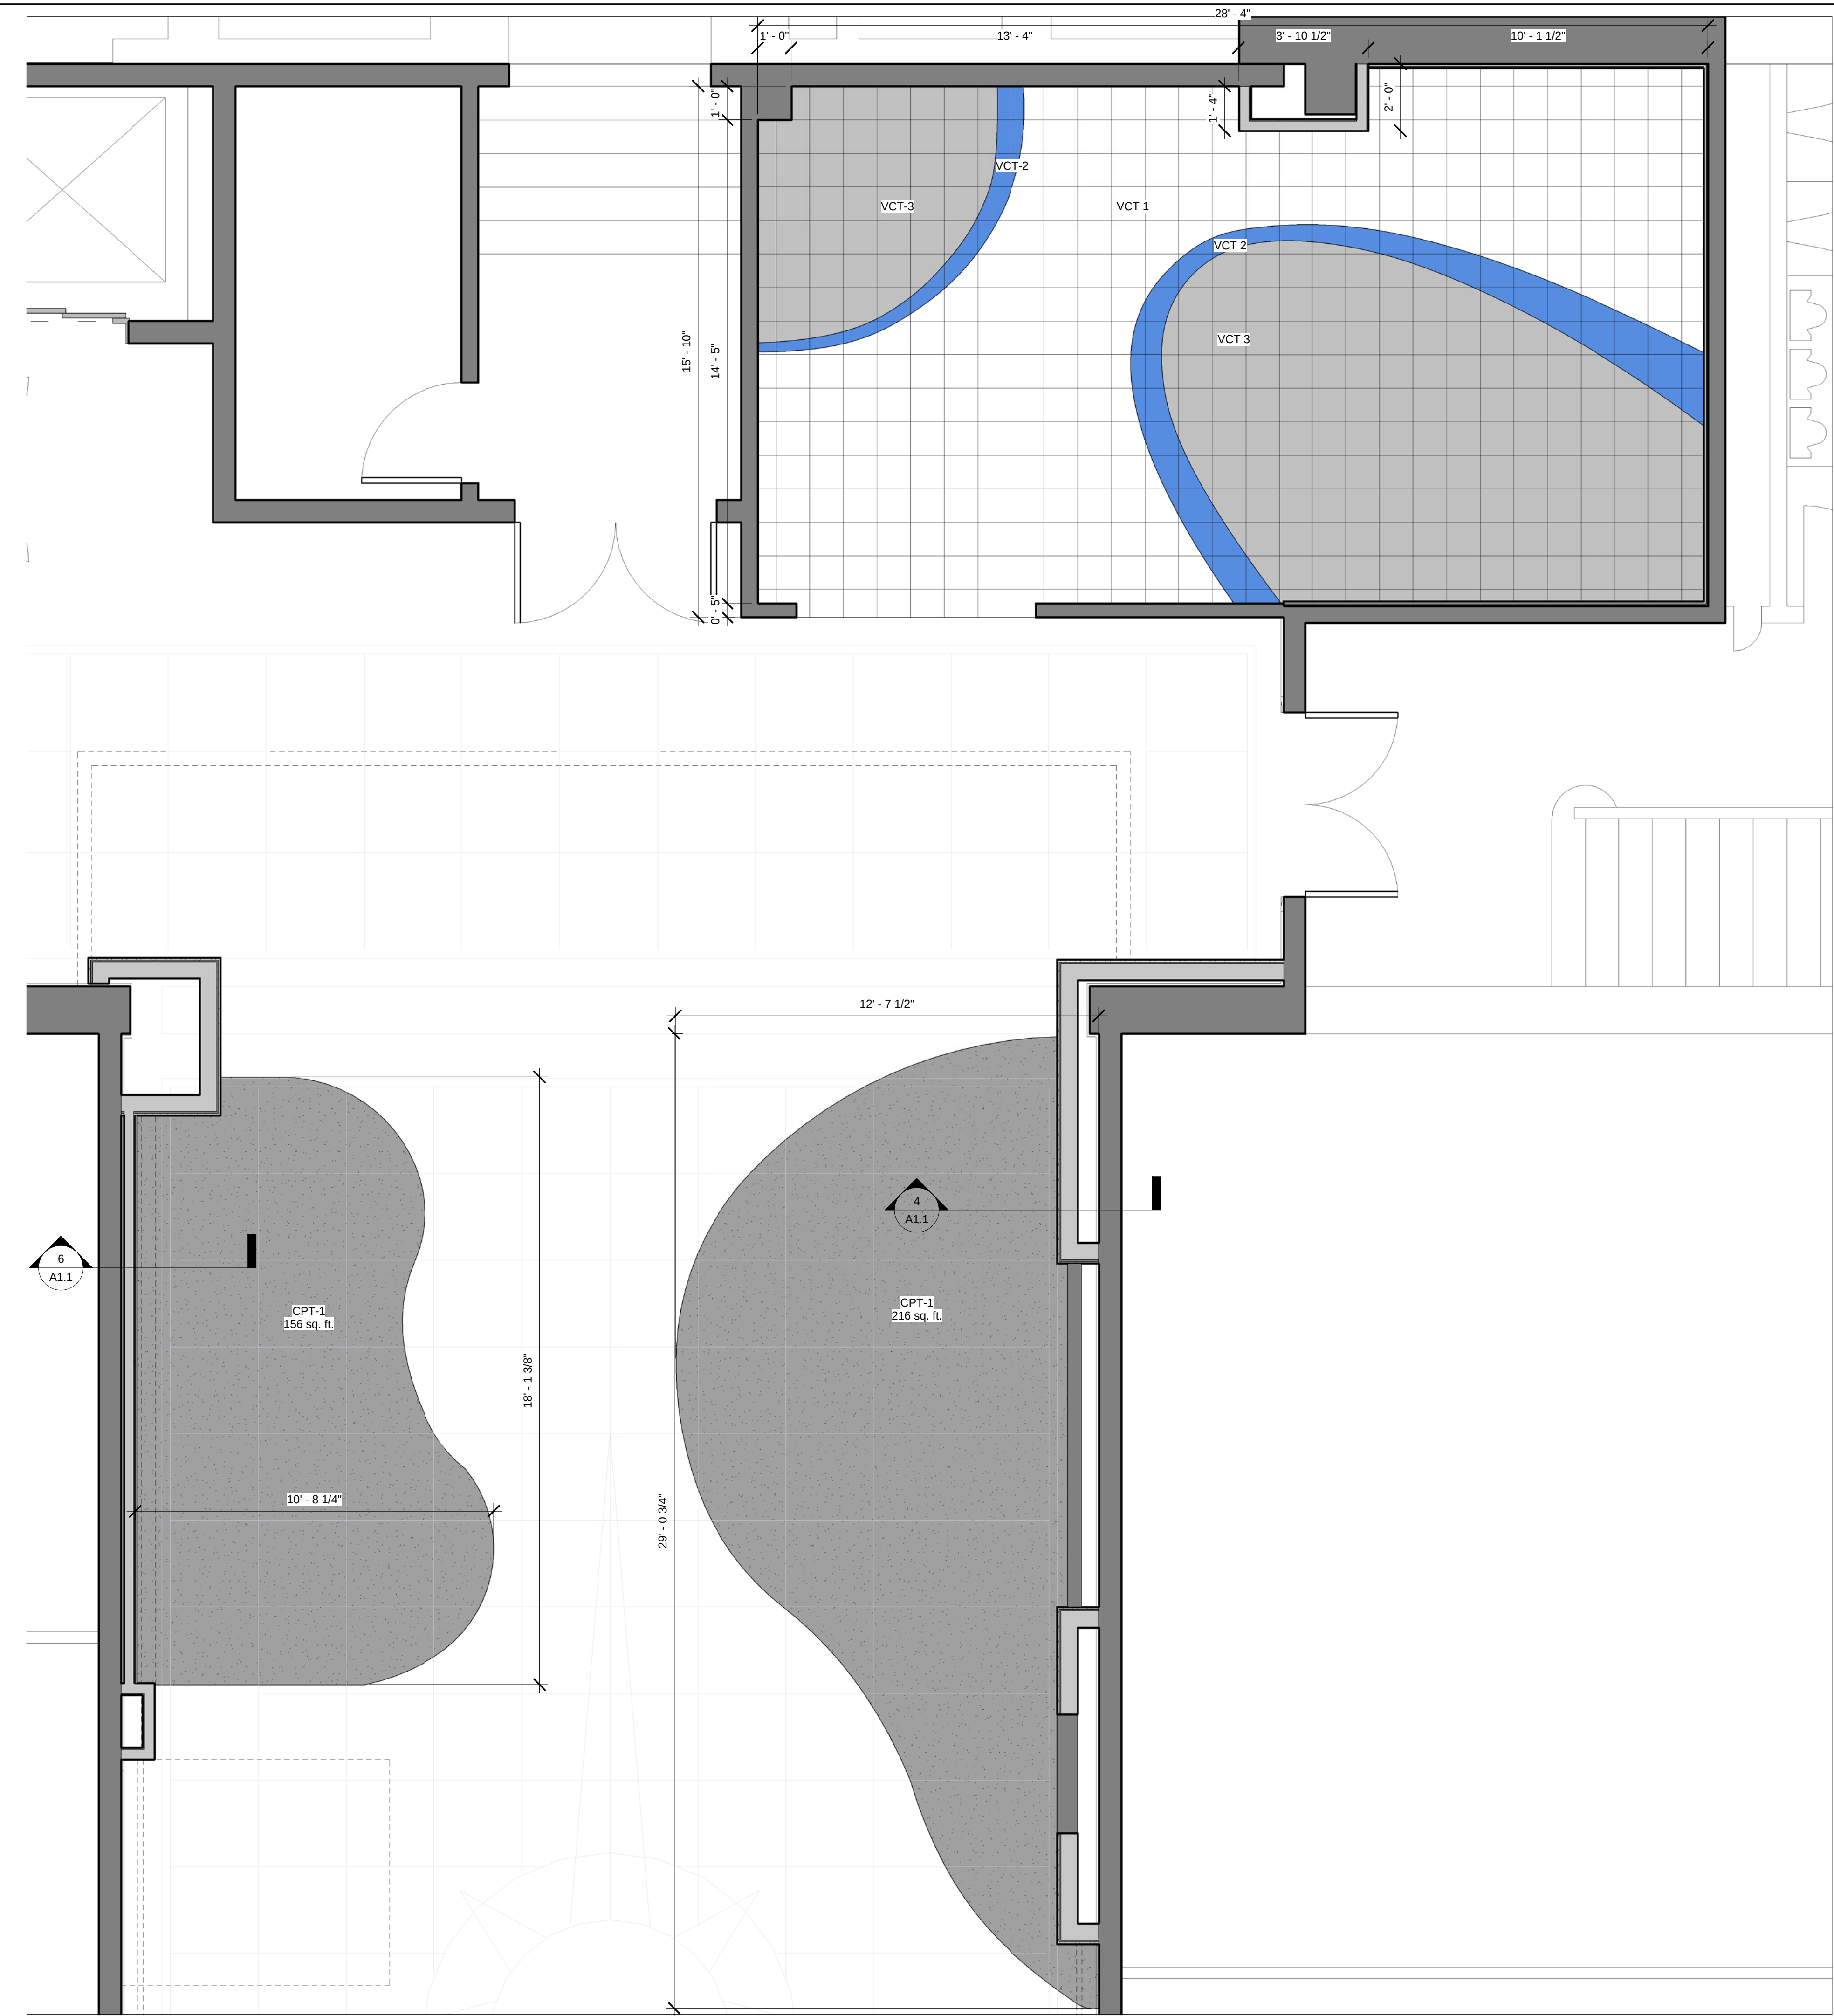

1 First Floor Level-Flooring Layout  
3/8" = 1'-0"

| FURNITURE SCHEDULE |     |                    |              |                            |                       |                           |        |                                                                       |
|--------------------|-----|--------------------|--------------|----------------------------|-----------------------|---------------------------|--------|-----------------------------------------------------------------------|
| KEY                | QTY | ITEM               | MANUFACTUER  | DESCRIPTION                | PRODUCT NO.           | DIMENSIONS                | FINISH | NOTES                                                                 |
| F1                 | 9   | LOBBY FURNITURE    | ERG CONTRACT | KATE LOUNGE UNIT           | 3650-KATE STRAIGHT    | 24" W, 18" H, 20" D       | TBS    | QTY 1 RIGHT OUTSIDE ARM 3664RST                                       |
| F2                 | 1   | LOBBY FURNITURE    | ERG CONTRACT | KATE LOUNGE UNIT           | 3658-KATE CORNER UNIT | 28" W, 18" H, 18" D.      | TBS    | -                                                                     |
| F3                 | 1   | LOBBY FURNITURE    | ARTOPEX      | ELEMENT ROUND              | ?                     | 36" DIA., 18" H           | TBS    | -                                                                     |
| F4                 | 9   | LOBBY FURNITURE    | ERG CONTRACT | KATE LOUNGE UNIT           | 3655 INSIDE MODULE    | 27.5" W, 18" H, 28" D     | TBS    | QTY 3 RIGHT OUTSIDE ARMS 3664 RST<br>QTY 3 LEFT OUTSIDE ARMS 3664 LST |
| F5                 | 3   | SNACK RM FURNITURE | ERG CONTRACT | DOVE CAFE SQUARE           | DM30S                 | 30" X 30"                 | TBS    | POLISHED CHROME BASE                                                  |
| F6                 | 12  | SNACK RM FURNITURE | ERG CONTRACT | COVO CAFE CHAIRS           | 270-FW                | 16.5" W, 15.5" D, 16.5" H | TBS    | -                                                                     |
| F7                 | 3   | LOBBY FURNITURE    | ARTOPEX      | ELEMENT SQUARE             | ?                     | ?                         | FINISH | -                                                                     |
| F8                 | 8   | SNACK RM FURNITURE | ERG CONTRACT | COVO BAR STOOL CHAIRS      | 278                   | 16.5" W, 15.5" D, 30" H   | TBS    | -                                                                     |
| F9                 | 4   | SNACK RM FURNITURE | ERG CONTRACT | DOVE CAFE SQUARE           | DM32GD                | 24" X 24"                 | TBS    | POLISHED CHROME BASE                                                  |
| F10                | 1   | LOBBY FURNITURE    | -            | -                          | -                     | -                         | -      | -                                                                     |
| F11                | 2   | SNACK RM FURNITURE | ERG CONTRACT | HARTFORD LOUNGE            | 3204                  | 48" W, 28" D, 20.5" H     | TBS    | -                                                                     |
| F12                | 1   | SNACK RM FURNITURE | ERG CONTRACT | HARTFORD OCCASIONAL TABLES | 3212                  | 20" W, 22" D, 17" H       | TBS    | -                                                                     |

# WALL FINISHES

| CODE  | ITEM                | LOCATION   | MANUFACTURER       | DESCRIPTION                                                                |
|-------|---------------------|------------|--------------------|----------------------------------------------------------------------------|
| P1    | PAINT               | WALLS      | SHERWIN WILLIAMS   | SW-6126 NAVAJO WHITE, FINISH: EGGSHELL                                     |
| P2    | PAINT               | WALLS      | SHERWIN WILLIAMS   | SW-7510 CHATEAU BROWN, FINISH: EGGSHELL                                    |
| P3    | PAINT               | WALLS      | SHERWIN WILLIAMS   | SW-7729 EDAMAME, FINISH: EGGSHELL                                          |
| P4    | PAINT               | WALLS      | SHERWIN WILLIAMS   | SW-6531 INDIGO, FINISH: EGGSHELL                                           |
| P-6   | PAINT               | DOOR       | SHERWIN WILLIAMS   | SW-6493 EBBTIDE, FINISH: EGGSHELL                                          |
| P-7   | PAINT               | CEILING    | SHERWIN WILLIAMS   | SW-7066 GRAY MATTERS, FINISH: EGGSHELL                                     |
| P-9   | PAINT               | WALLS      | SHERWIN WILLIAMS   | SW-7550 RESORT TAN, FINISH: EGGSHELL                                       |
| WV-1  | WOOD VENEER         | WALLS      | TREEFROG           | 60404 WALNUT STRAIGHT GRAIN,                                               |
| LAM-1 | LAMINATE PANEL      | WALL PANEL | LAMIN-ART          | #2720-A CASHMERE BIRDSEY CHRYSALIS FINISH                                  |
| ST-1  | STONE WALL MATERIAL | WALL       | REAL STONE SYSTEMS | RSIWSP-S3D REAL STONE SIERRA SHADOW STONE 6X24                             |
| ST-2  | STONE WALL MATERIAL | WALL       | REAL STONE SYSTEMS | RSHTA-SRS REAL STONE SIERRA HEARTH TYPE A (TILE MUST BE CUT TO FIT MANTEL) |

| BASE TRIM |             |          |                          |              |                    |
|-----------|-------------|----------|--------------------------|--------------|--------------------|
| CODE      | ITEM        | LOCATION | MANUFACTURER             | PART #       | DESCRIPTION        |
| RB1       | RUBBER BASE | WALLS    | Johnsonite or Equivalent | 44-Darkbrown | 4" vinyl base trim |

| CEILING |              |                 |                                                                                                                               |         |
|---------|--------------|-----------------|-------------------------------------------------------------------------------------------------------------------------------|---------|
| CODE    | ITEM         | MANUFACTURER    | DESCRIPTION                                                                                                                   | REMARKS |
| GWB     | GYPSUM BOARD | -               | -                                                                                                                             | -       |
| ACT-1   | Ceiling Tile | USG CORPORATION | Olympia Micro Clima Plus 50 NRC Panels<br>Item Number 4231.<br>Fineline Bevel, 5/8" Thick, 2'x2', Metal Suspension: DXF 9/16" | White   |
|         |              |                 |                                                                                                                               |         |

| FLOOR FINISHES |             |                |              |                   |                     |
|----------------|-------------|----------------|--------------|-------------------|---------------------|
| CODE           | ITEM        | LOCATION       | MANUFACTURER | PART #            | DESCRIPTION         |
| CPT - 1        | CARPET TILE | LOBBY FLOOR    | INTERFACE    | REDESIGN - 102570 | -                   |
| VCT - 1        | VINYL TILE  | SNACK RM FLOOR | MANNINGTON   | 121 SILVER WHITE  | DESIGNER ESSENTIALS |
| VCT - 2        | VINYL TILE  | SNACK RM FLOOR | MANNINGTON   | 250 SAPPHIRE      | DESIGNER ESSENTIALS |
| VCT - 3        | VINYL TILE  | SNACK RM FLOOR | MANNINGTON   | 122 GLACIER       | DESIGNER ESSENTIALS |

# PLANTER DETAILS

**FRONT ELEVATION**

**SIDE ELEVATION**

**PLAN VIEW**

| DOOR SCHEDULE |         |          |---------------|---------|----------|-----------|------|------|---------------|--------------|---------|------------------|-------|----------|-------------|-------------|-------------|------------|---------|-------------|--------|-------|--------------|-----------|----------------|---------------------------------------|
| KEY           | DOOR    |          |           |      |      |               |              |         | RATING (MINUTES) | FRAME |          |             |             |             | HARDWARE   |         |             |        |       |              | FOOTNOTES |                |                                       |
|               | WIDTH   | HEIGHT   | THICKNESS | TYPE | PAIR | FACE MATERIAL | CONSTRUCTION | GLAZING |                  | TYPE  | MATERIAL | HEAD DETAIL | JAMB DETAIL | SILL DETAIL | SET NUMBER | LOCKING | KICK PLATES | CLOSER | SEALS | PANIC DEVICE |           | POWER OPERATED | ELECTRIC HOLD OPEN                    |
| 100           | 6'-4"   | 7'-0"    | 1 3/4"    | C    | X    | AL            | -            | T       | -                | N/A   | -        | -           | -           | -           | -          | -       | -           | -      | -     | -            | -         | -              | REUSE EXISTING LOCK CYLINDERS & CORES |
| 101           | 6'-4"   | 7'-0"    | 1 3/4"    | C    | X    | AL            | -            |         | -                | N/A   | -        | -           | -           | -           | -          | -       | -           | -      | -     | -            | -         | -              | REUSE EXISTING LOCK CYLINDERS & CORES |
| 102           | 6'-4"   | 7'-0"    | 1 3/4"    | C    | X    | AL            | -            |         | -                | N/A   | -        | -           | -           | -           | -          | -       | -           | -      | -     | -            | -         | -              | REUSE EXISTING LOCK CYLINDERS & CORES |
| 103           | 6'-4"   | 10'- 10" | 5/8"      | B    | X    | GL            | -            | T       | -                | N/A   | -        | -           | -           | -           | -          | -       | -           | -      | -     | -            | -         | -              | -                                     |
| 104           | 6'-4"   | 10'- 10" | 5/8"      | B    | X    | GL            | -            | T       | -                | N/A   | -        | -           | -           | -           | -          | -       | -           | -      | -     | -            | -         | -              | -                                     |
| 105           | 3'-0" ? | 7'- 0"   | 5/8"      | A    | X    | WD            | SC           | F       | 20               | N/A   | -        | -           | -           | -           | -          | -       | -           | -      | -     | -            | -         | -              | -                                     |
| 106           | 3'-0" ? | 7'- 0"   | 5/8"      | A    | X    | WD            | SC           | F       | 20               | N/A   | -        | -           | -           | -           | -          | -       | -           | -      | -     | -            | -         | -              | REUSE EXISTING LOCK CYLINDERS & CORES |
| 107           | 6'-0"   | 7'- 0"   | 1 3/4"    | D    | X    | WD            | SC           | F       | 20               | N/A   | -        | -           | -           | -           | -          | -       | -           | -      | -     | -            | -         | -              | REUSE EXISTING LOCK CYLINDERS & CORES |

 
| ABBREVIATIONS:                |                      |                        |                       |                     |  | SEALS: |  |
|-------------------------------|----------------------|------------------------|-----------------------|---------------------|--|--------|--|
| AL: ALUMINUM                  | HM: HOLLOW METAL     | SD/ SMOKE DETECTOR-    | T: TEMPERED GLAZING   | 1. LIGHT            |  |        |  |
| BR: BIRCH VENEER              | WD: HARDWOOD VENEER; | MAGNETIC               | I: INSULATED GLAZING  | 2. SMOKE            |  |        |  |
| GL: GLASS                     | NATURAL FINISH       | MHOD: HOLD OPEN DEVICE | AD: ANODIZED          | 3. WEATHER          |  |        |  |
| PG: PAINT GRADE               | PL: PLASTIC LAMINATE | SC: SOLID CORE         | F: FIRE RATED GLAZING | 4. ACOUSTICAL       |  |        |  |
| SS: STAINLESS STEEL           | PT: PAINT            | W: WIRED GLAZING       | SS: STAINLESS STEEL   |                     |  |        |  |
| LOCKING:                      |                      |                        |                       |                     |  |        |  |
| 1. PANIC HARDWARE W/ EXTERIOR |                      | 3. CLASSROOM           | 6. STORE DOOR LOCK    | 9. STORE RM/CLOSET  |  |        |  |
| 2. PRIVACY                    |                      | 4. DUMMY TRIM          | 7. PASSAGE            | 10. DORMITORY/EXIT  |  |        |  |
| 3. EXTERIOR                   |                      | 5. PUSH PULL           | 8. OFFICE/ENTRANCE    | 11. REQUEST TO EXIT |  |        |  |

## F-1

0' - 6" 0' - 10"


2' - 9" 3' - 4"

ELITE  
D



- 1 REPLACE FAIN COIL UNIT
- 2 RELOCATION OF SUPPLY VENT

|                     |               |
|---------------------|---------------|
| TSU                 |               |
| New Mechanical Unit |               |
| Project Number      | LRC-0001      |
| Date                | 7/27/2011     |
| Drawn By            | F. JOLIVETTE  |
| Checked By          | BRIAN GAFFORD |
| M1.0                |               |
| Scale               | As indicated  |

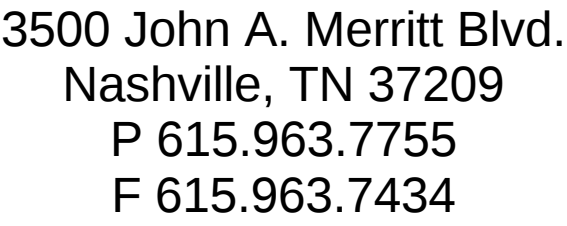

# LRC Lobby Renovation

[illegible]

# MECHANICAL ELEVATIONS

|                |               |
|----------------|---------------|
| Project Number | LRC-000       |
| Date           | 7/27/201      |
| Drawn By       | F. JOLIVETT   |
| Checked By     | BRIAN GAFFORI |

# M2.0

Scale As indicated



## NOTES

- ① RELOCATION OF DUCT TO BE IN MECHANICAL SCOPE
- ② REPAIR EXISTING HOLE TO BE IN WALL FINISH CONTRACT SCOPE
- ③ RELOCATION OF HVAC INTAKE TO BE DONE BY WALL FINISH CONTRACTOR
- ④ HVAC INTAKE TO BE DONE BY WALL FINISH CONTRACTOR



3500 John A. Merritt Blvd.  
Nashville, TN 37209  
P 615.963.7755  
F 615.963.7434

www.tnstate.edu

LRC Lobby  
Renovation

| No. | Description | Date |
|-----|-------------|------|
|     |             |      |
|     |             |      |

TSU

EXISTING HVAC DUCT  
WORK 1ST FLOOR

|                |           |
|----------------|-----------|
| Project Number | LRC-0001  |
| Date           | 7/27/2011 |
| Drawn By       | N/A       |
| Checked By     | Checker   |

M3

Scale

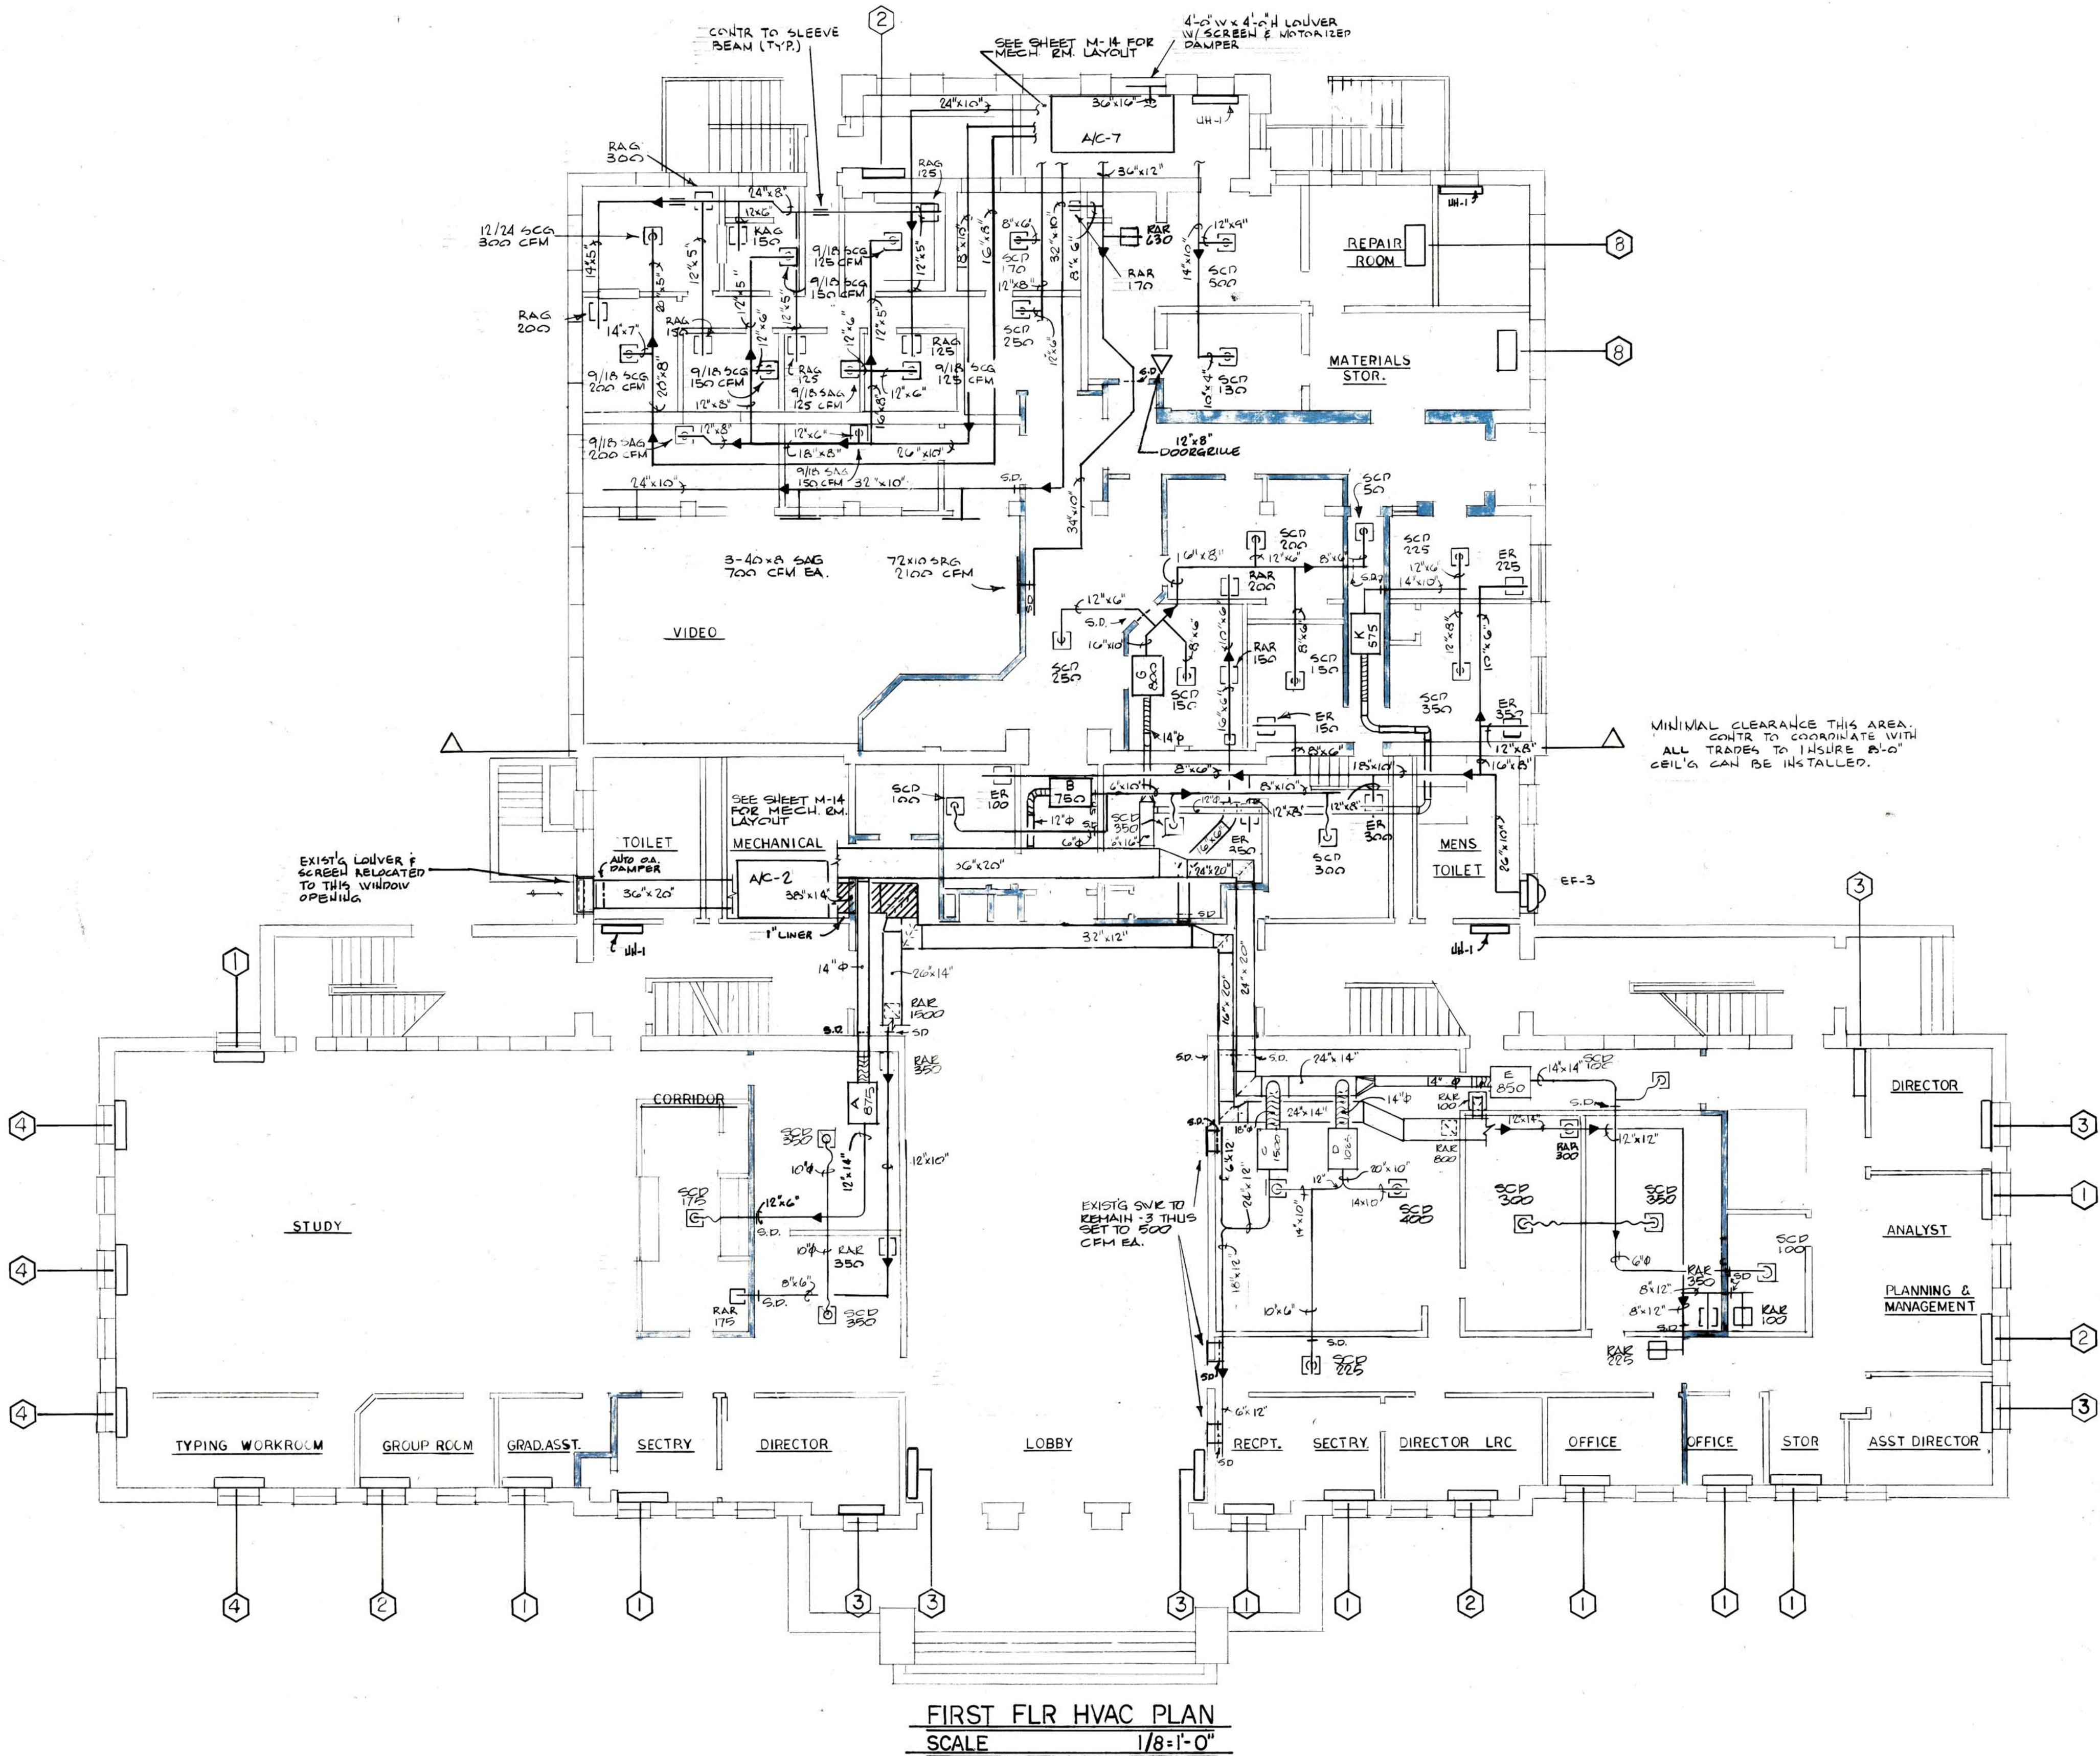

**JACKSON & HARRIS**  
ARCHITECTS  
PLANNERS  
NASHVILLE, TENNESSEE

**LEARNING RESOURCES CENTER**  
RENOVATION OF OLD LIBRARY  
TENNESSEE STATE UNIVERSITY  
STATE BOARD OF REGENTS

PROJECT No. \_\_\_\_\_  
DATE \_\_\_\_\_  
DRAWN BY \_\_\_\_\_  
CHECKED BY \_\_\_\_\_  
APPROVED BY \_\_\_\_\_  
REVISED \_\_\_\_\_

SHEET No.  
**M-7**  
of 18

3500 John A. Merritt Blvd.  
Nashville, TN 37209  
P 615.963.7755  
F 615.963.7434

[www.tnstate.edu](http://www.tnstate.edu)

# LRC Lobby Renovation

[illegible]

TSU

## EXISTING HVAC PIPING 1ST FLOOR

Project Number LRC-0001

7/27/2013


Drawn By N/A

# M4

Scale

| CONDENSATE RETURN UNIT SCHEDULE |                |  |
|---------------------------------|----------------|--|
| SERVICE                         | CRU-1          |  |
| CAPACITY - E.D.R.               | 10000          |  |
| PUMP G.P.M.                     | 15             |  |
| DISCH. PRESS. - P.S.I.          | 40             |  |
| PUMP R.P.M.                     | 1750           |  |
| H.P.                            | 2 @ 3/4 HP EA. |  |
| ELECTRICAL                      | 208-3          |  |
| RECEIVER SIZE                   | 12 GAL.        |  |
| TYPE                            | DUPLEX         |  |
| REMARKS                         |                |  |

NOTES  
1. UNIT TO HAVE CAST IRON RECEIVER WITH  
LEVEL GAUGE, MAG. STARTER & FLOAT  
SWITCH W/ ALTR. ASSEMBLY

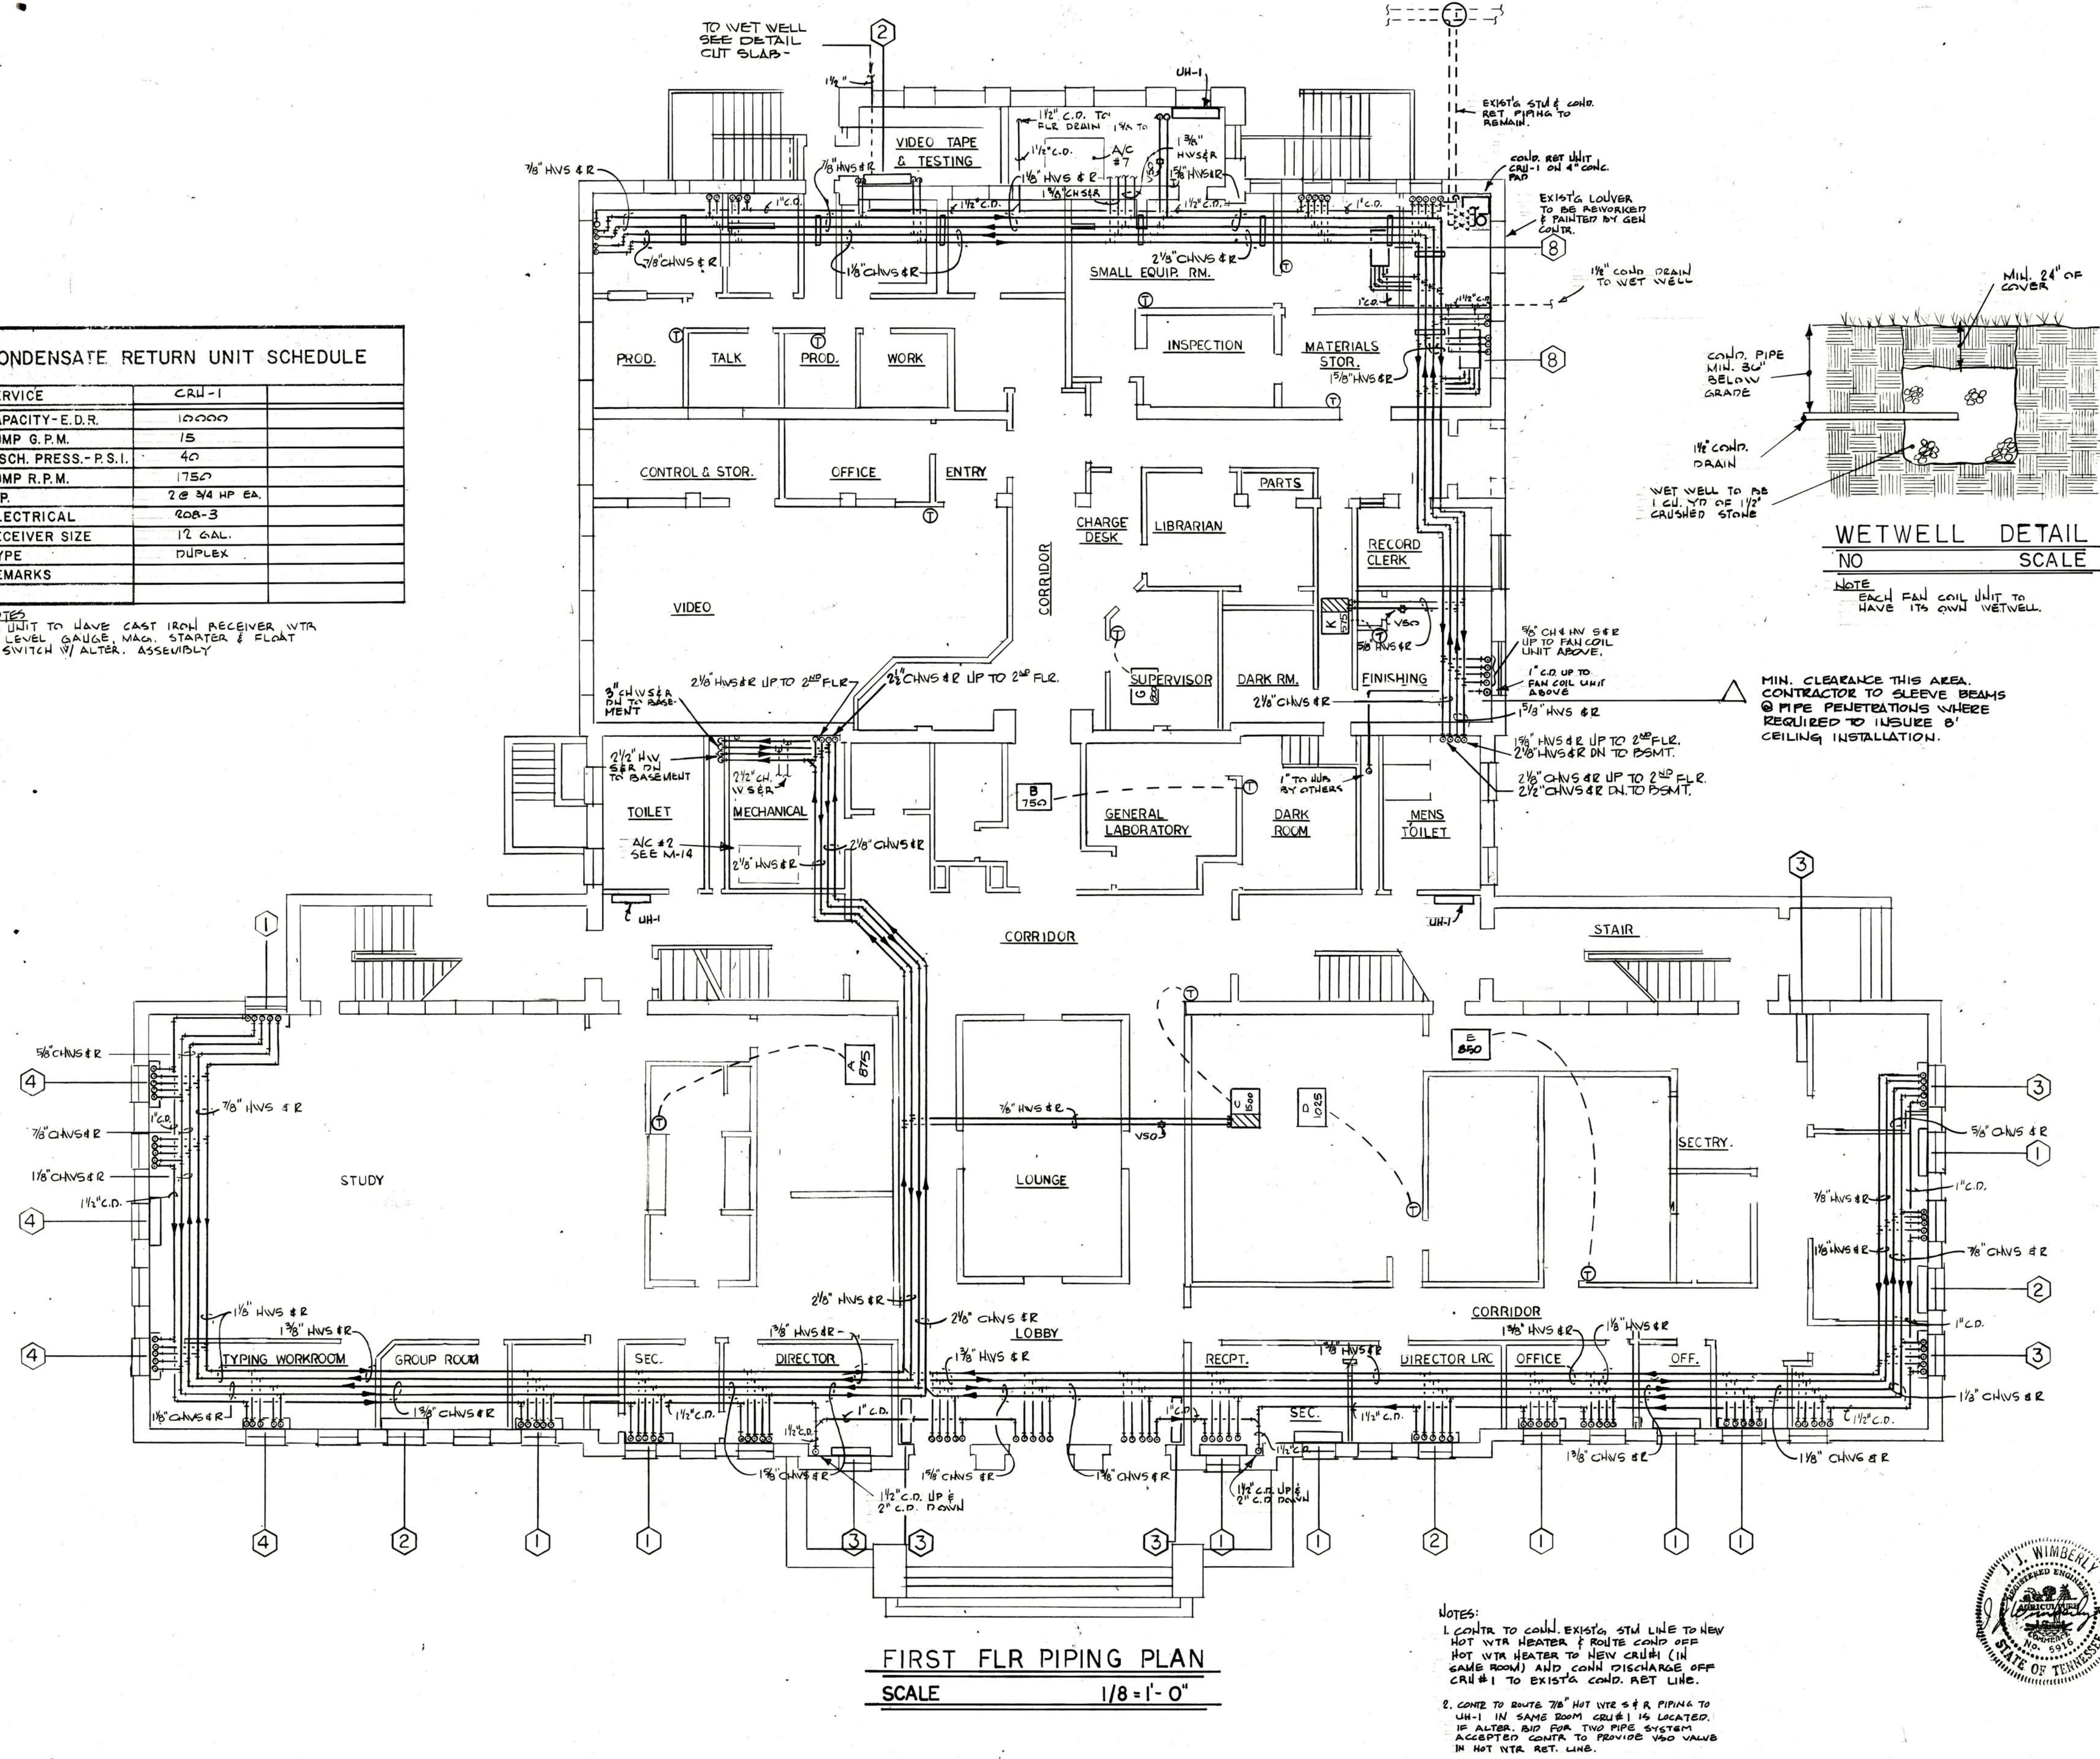


PROJECT No.  
DATE  
DRAWN BY  
CHECKED BY  
APPROVED BY  
REVISED

**LEARNING RESOURCES**  
RENOVATION OF OLD LIBRARY  
**TENNESSEE STATE UNIVERSITY**  
STATE BOARD OF REGENTS  
**CENTER**  
**NASHVILLE**


**JACKSON & HARRIS**  
**ARCHITECTS PLANNERS**  
NASHVILLE, TENNESSEE

|           |
|-----------|
| SHEET No. |
| M-11      |

 of 18



PANELS A & B FEED BY DPA  
PANEL B HAS 13 OPEN SLOTS FOR ADDED CIRCUITS  
PANEL A HAS 6 OPEN SLOTS FOR ADDED CIRCUITS  
P1E DENOTES SWITCHED EMERGENCY BATTERY  
BACKUP FIXTURE CONNECTED SUCH THAT FIXTURE  
IS ILLUMINATED IN THE EVENT OF POWER LOSS.

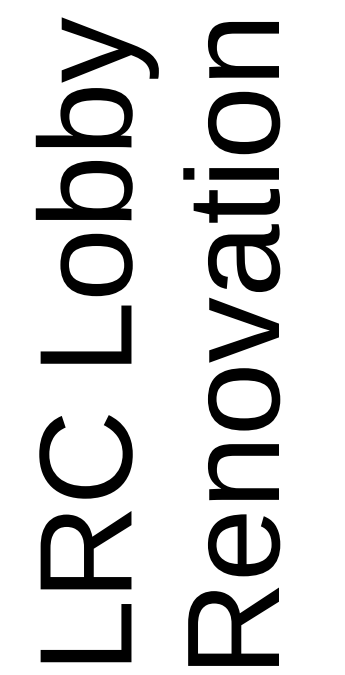

|       |              |
|-------|--------------|
| Scale | As indicated |
|-------|--------------|

